
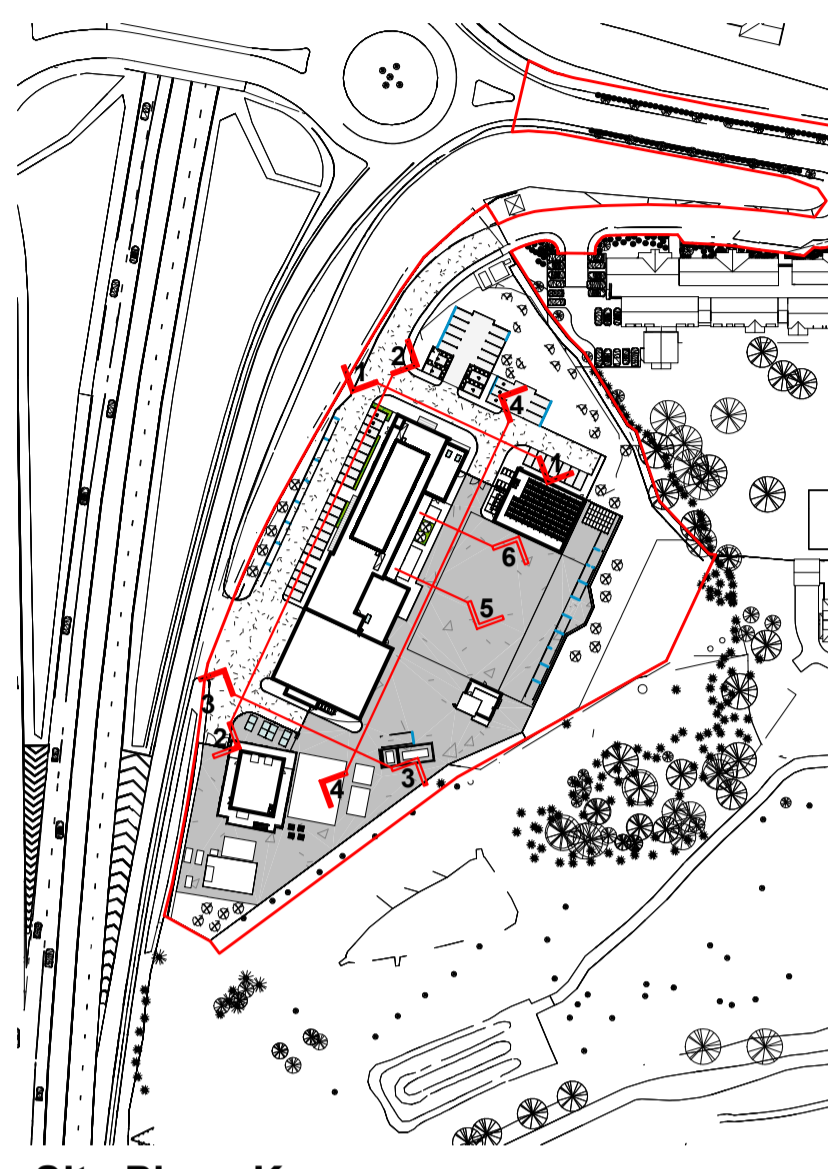


- This drawing is the copyright of HNW Architects Ltd No. 3589904
 - All dimensions must be verified on site prior to construction.
 - Do not scale this drawing except for Planning Application purposes.
 - Ordnance Survey Licence No. 100000200
 - Only PDF issues of this drawing are controlled. All other formats of this drawing (e.g. dwg, AutoCAD or .rvt files) are uncontrolled and are used at your own risk.
 - This drawing must not be copied, transmitted or passed to a third party, without written consent

Rev	Amendments	By	Chkd	Date
P7	PLANNING	TJ	MB	08/10/2020

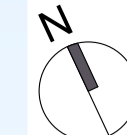

Site Plan - Key
1:2000


Material Schedule	
Tag	Material
1	Brick - Buff
2	Eurobond - Dark Grey
3	Glass Door
4	Curtain Walling
5	Glazed Coloured Panel
6	Metal Door
7	Window
8	Louvre
9	Up and Over Appliance Door
10	Appliance Bay Canopy
12	Steel Frame
13	CAT Ladder
14	Canopy
22	PPC Aluminium Panels - Gold/Bronze
24	Safety Rail
26	Louvered Door
27	Brick - Textured Buff
28	Brick - Dark Grey

Note:
Design Proposals require further coordination with Structural, Civil and MEP Engineers

Note:
All measurements are preliminary/ approximate & subject to utilities search, legal boundaries and detailed layouts/design development through consultation.

Note: Coordination
This drawing is subject to further coordination. Resultant amendments may be necessary following receipt and coordination of Consultant/ Building Control/ Fire/ Acoustic Engineer and Subcontractor/ Supplier Information.

 Note:
This drawing is to be read in conjunction with all relevant Architectural, Structural, Civil, MEP, and Specialist Subcontractor drawings, specifications schedules and information.



Scale Bar 1:200@A1

Project
Willmott Dixon
Horsham Fire Station and Training Centre

Drawn by: TJ
Checked by: MB
HNW Project No.: 19038
Date Created: DEC 19


Scale: A1- As indicated

Drawing Title: Fire Station and Training Centre - Building Elevations


Drawing status: Preliminary
Revision: P7

Drawing Name: HBC-HNW-FS-ZZ-DR-A-2310


61 North Street, Chichester, West Sussex, PO19 1NB

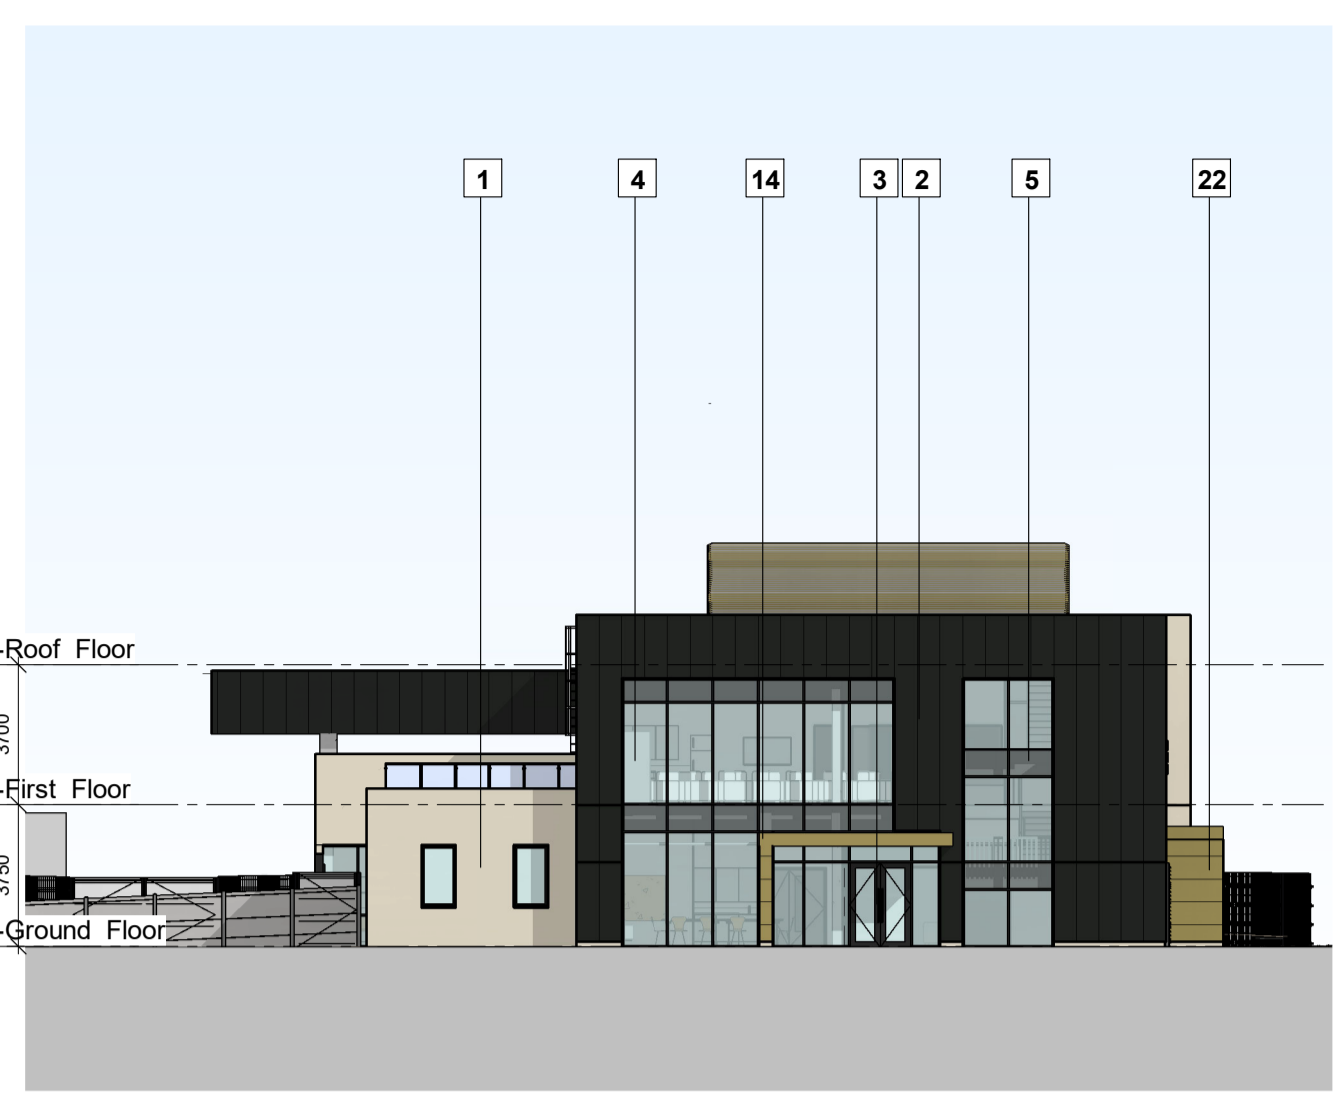

1 Elevation North
1:200

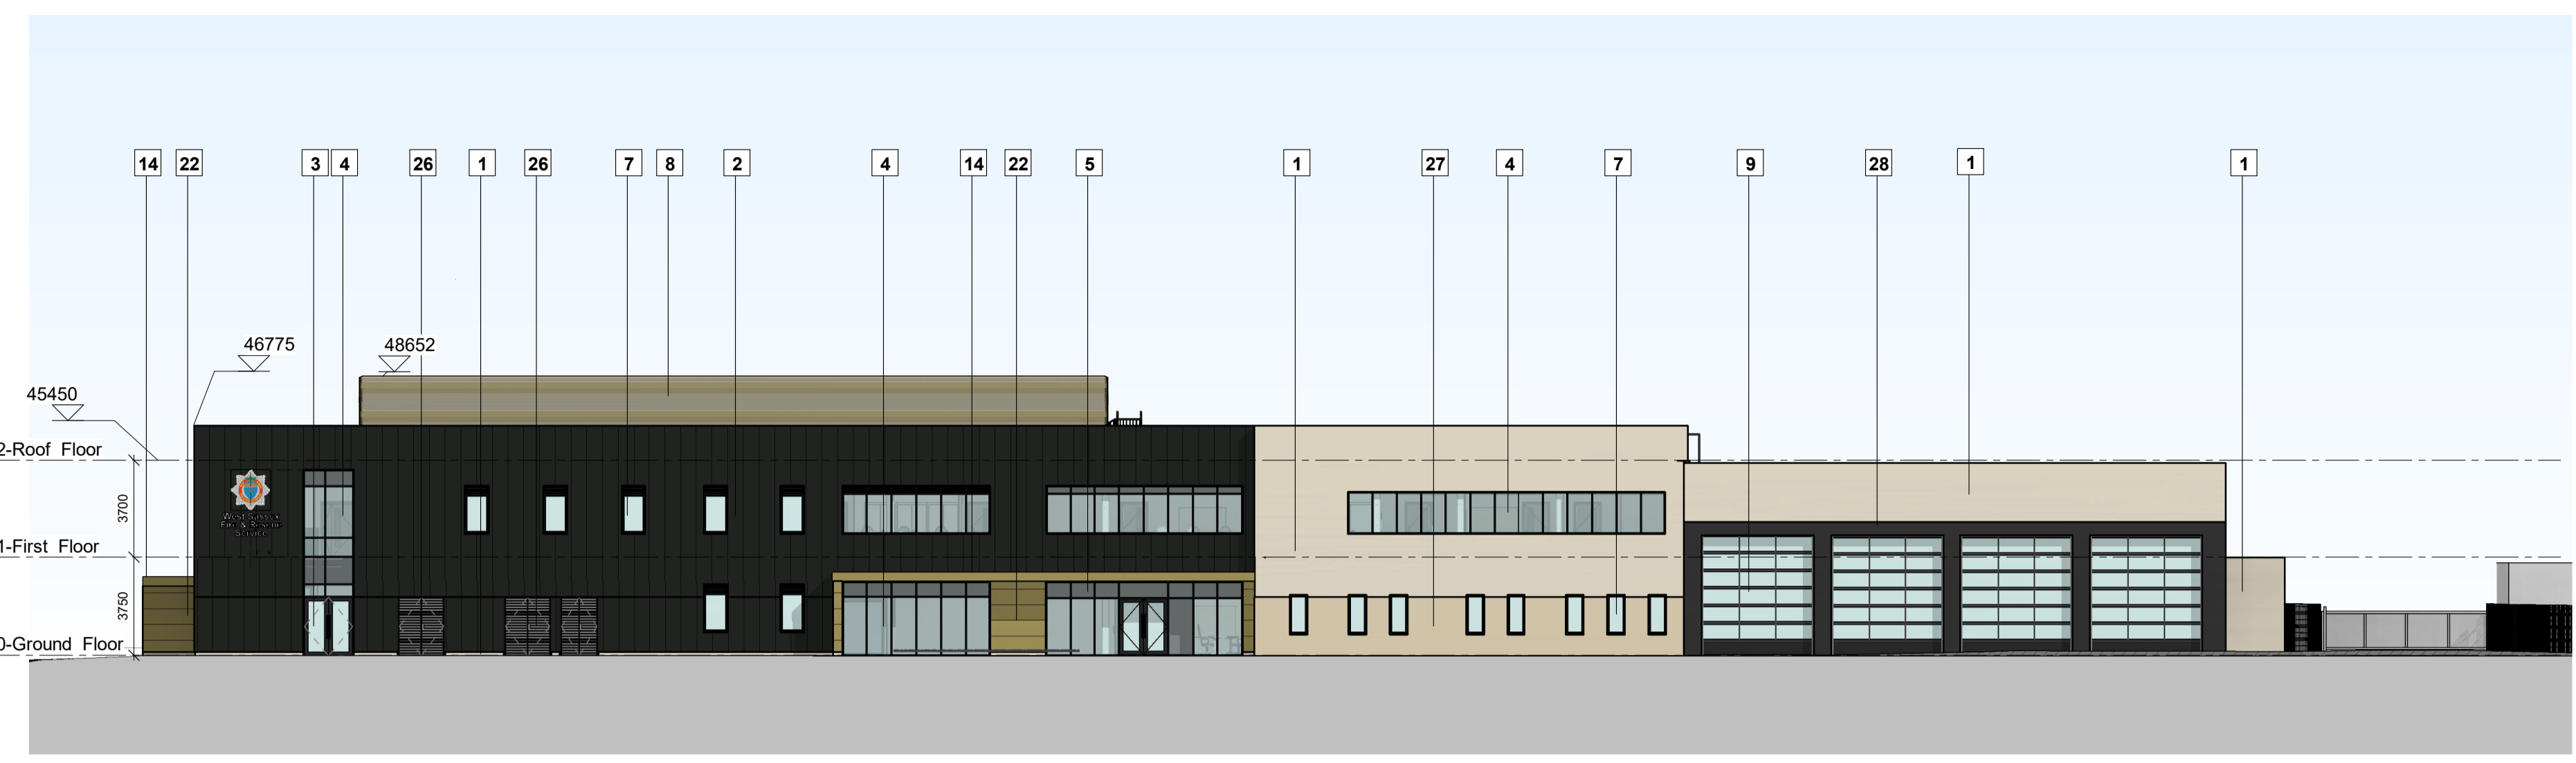


2 Elevation West
1:200

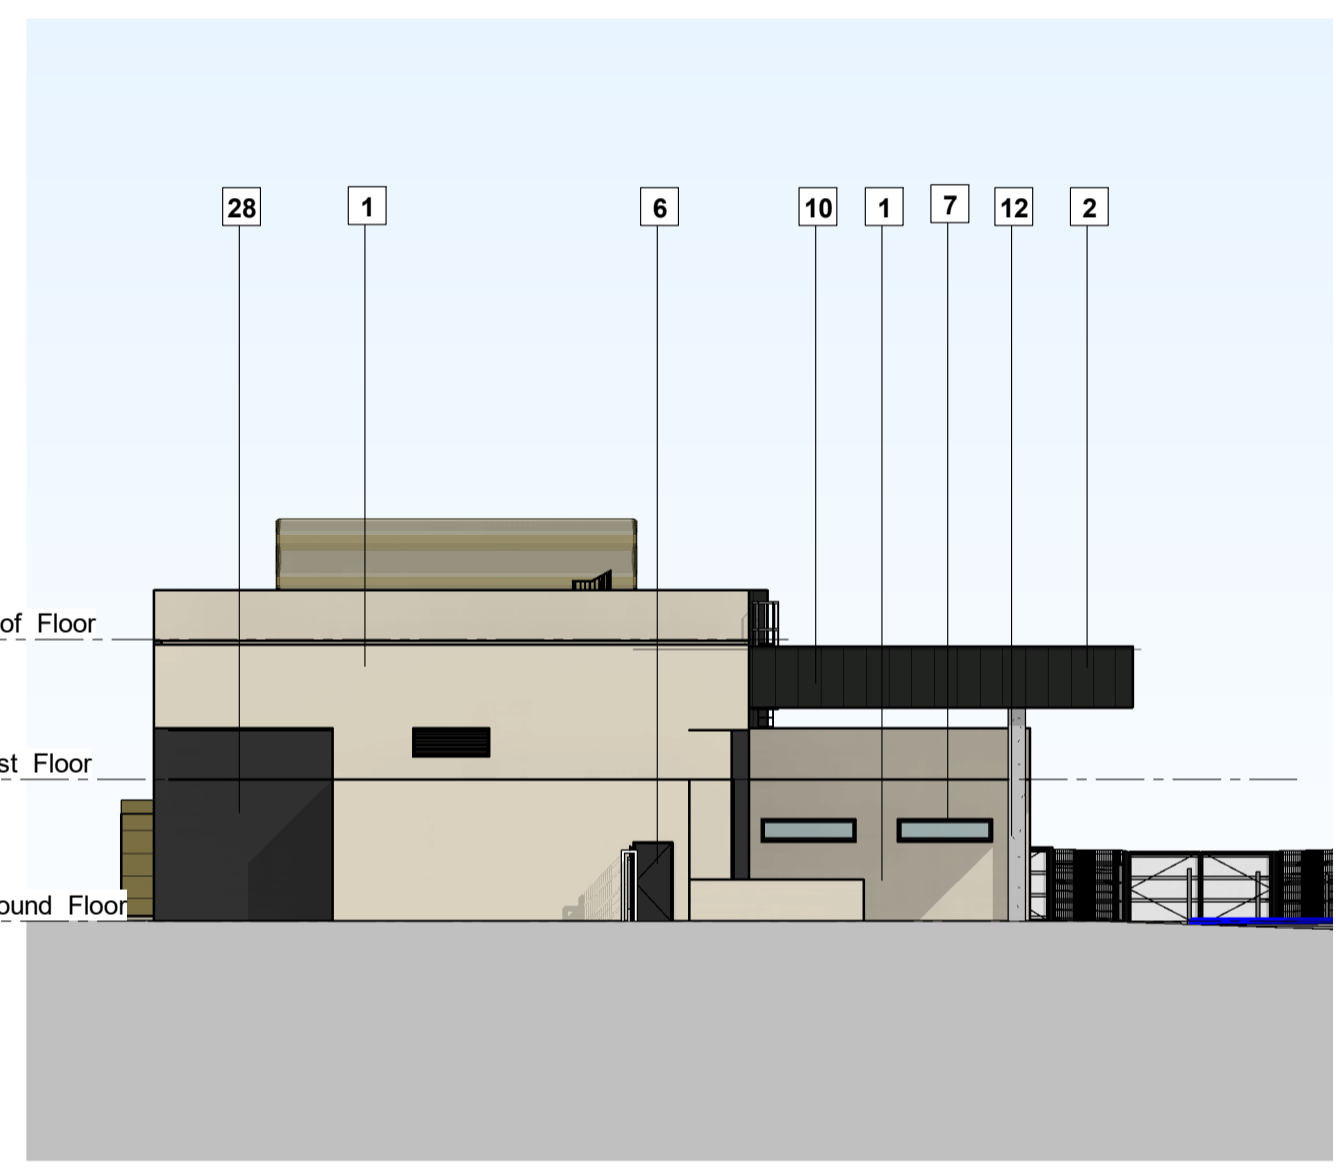


3 Elevation South
1:200



4 Elevation East
1:200

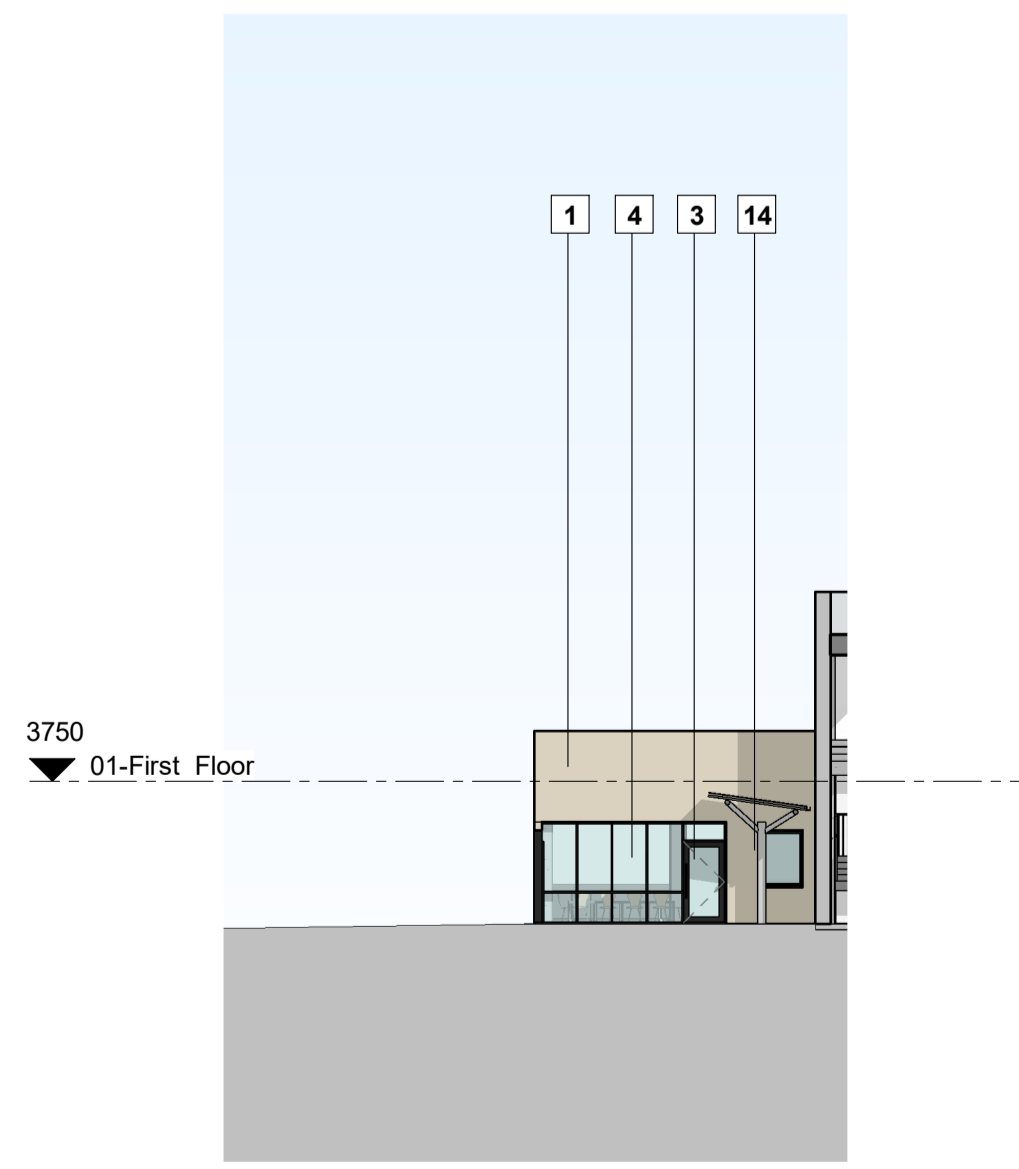

5 Elevation - Quiet Room
1:200

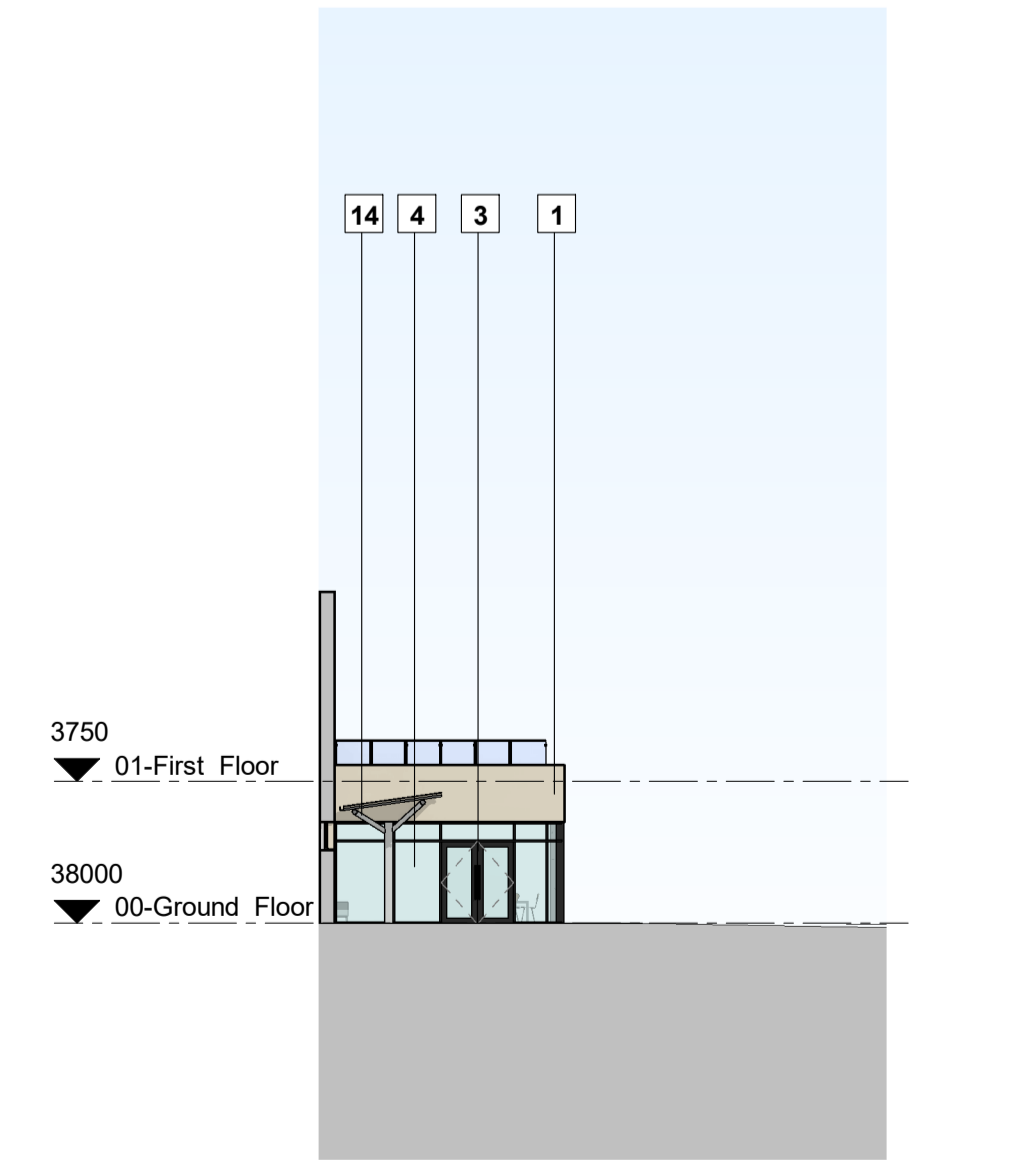

6 Elevation - Restaurant
1:200

- This drawing is the copyright of HNW Architects Ltd No. 3589904
 - All dimensions must be verified on site prior to construction.
 - Do not scale this drawing except for Planning Application purposes.
 - Ordnance Survey Licence No. 100000200
 - Only PDF issues of this drawing are controlled. All other formats of this drawing (e.g. dwg, AutoCAD or .rvt files) are uncontrolled and are used at your own risk.
 - This drawing must not be copied, transmitted or passed to a third party, without written consent


Rev	Amendments	By	Chkd	Date
P1	Draft Issue	TJ	MB	12/12/2019
P2	Stage 2 Concept Design Issue	TJ	MB	20/12/2019
P3	DRAFT PLANNING	TJ	MB	31/03/2020
P4	DRAFT PLANNING	DH	MCZ	26/05/2020
P5	DRAFT PLANNING	DH	MCZ	22/09/2020
P6	PLANNING	TJ	MB	08/10/2020



A Building Section A
1 : 100




B Building Section B
1 : 100

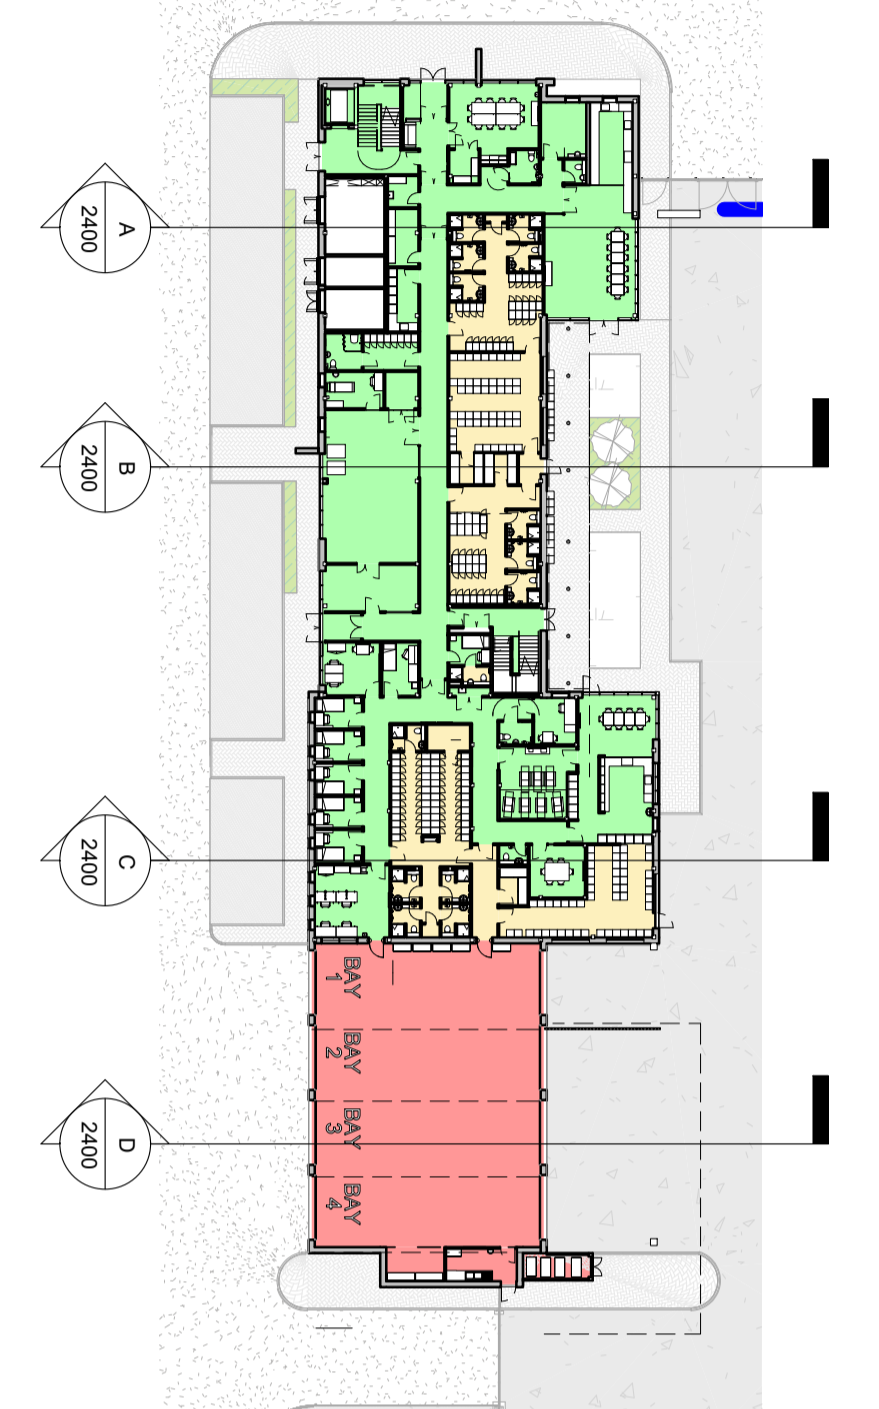

Key - Ground Floor Plan Sections
1 : 500



C Building Section C
1 : 100

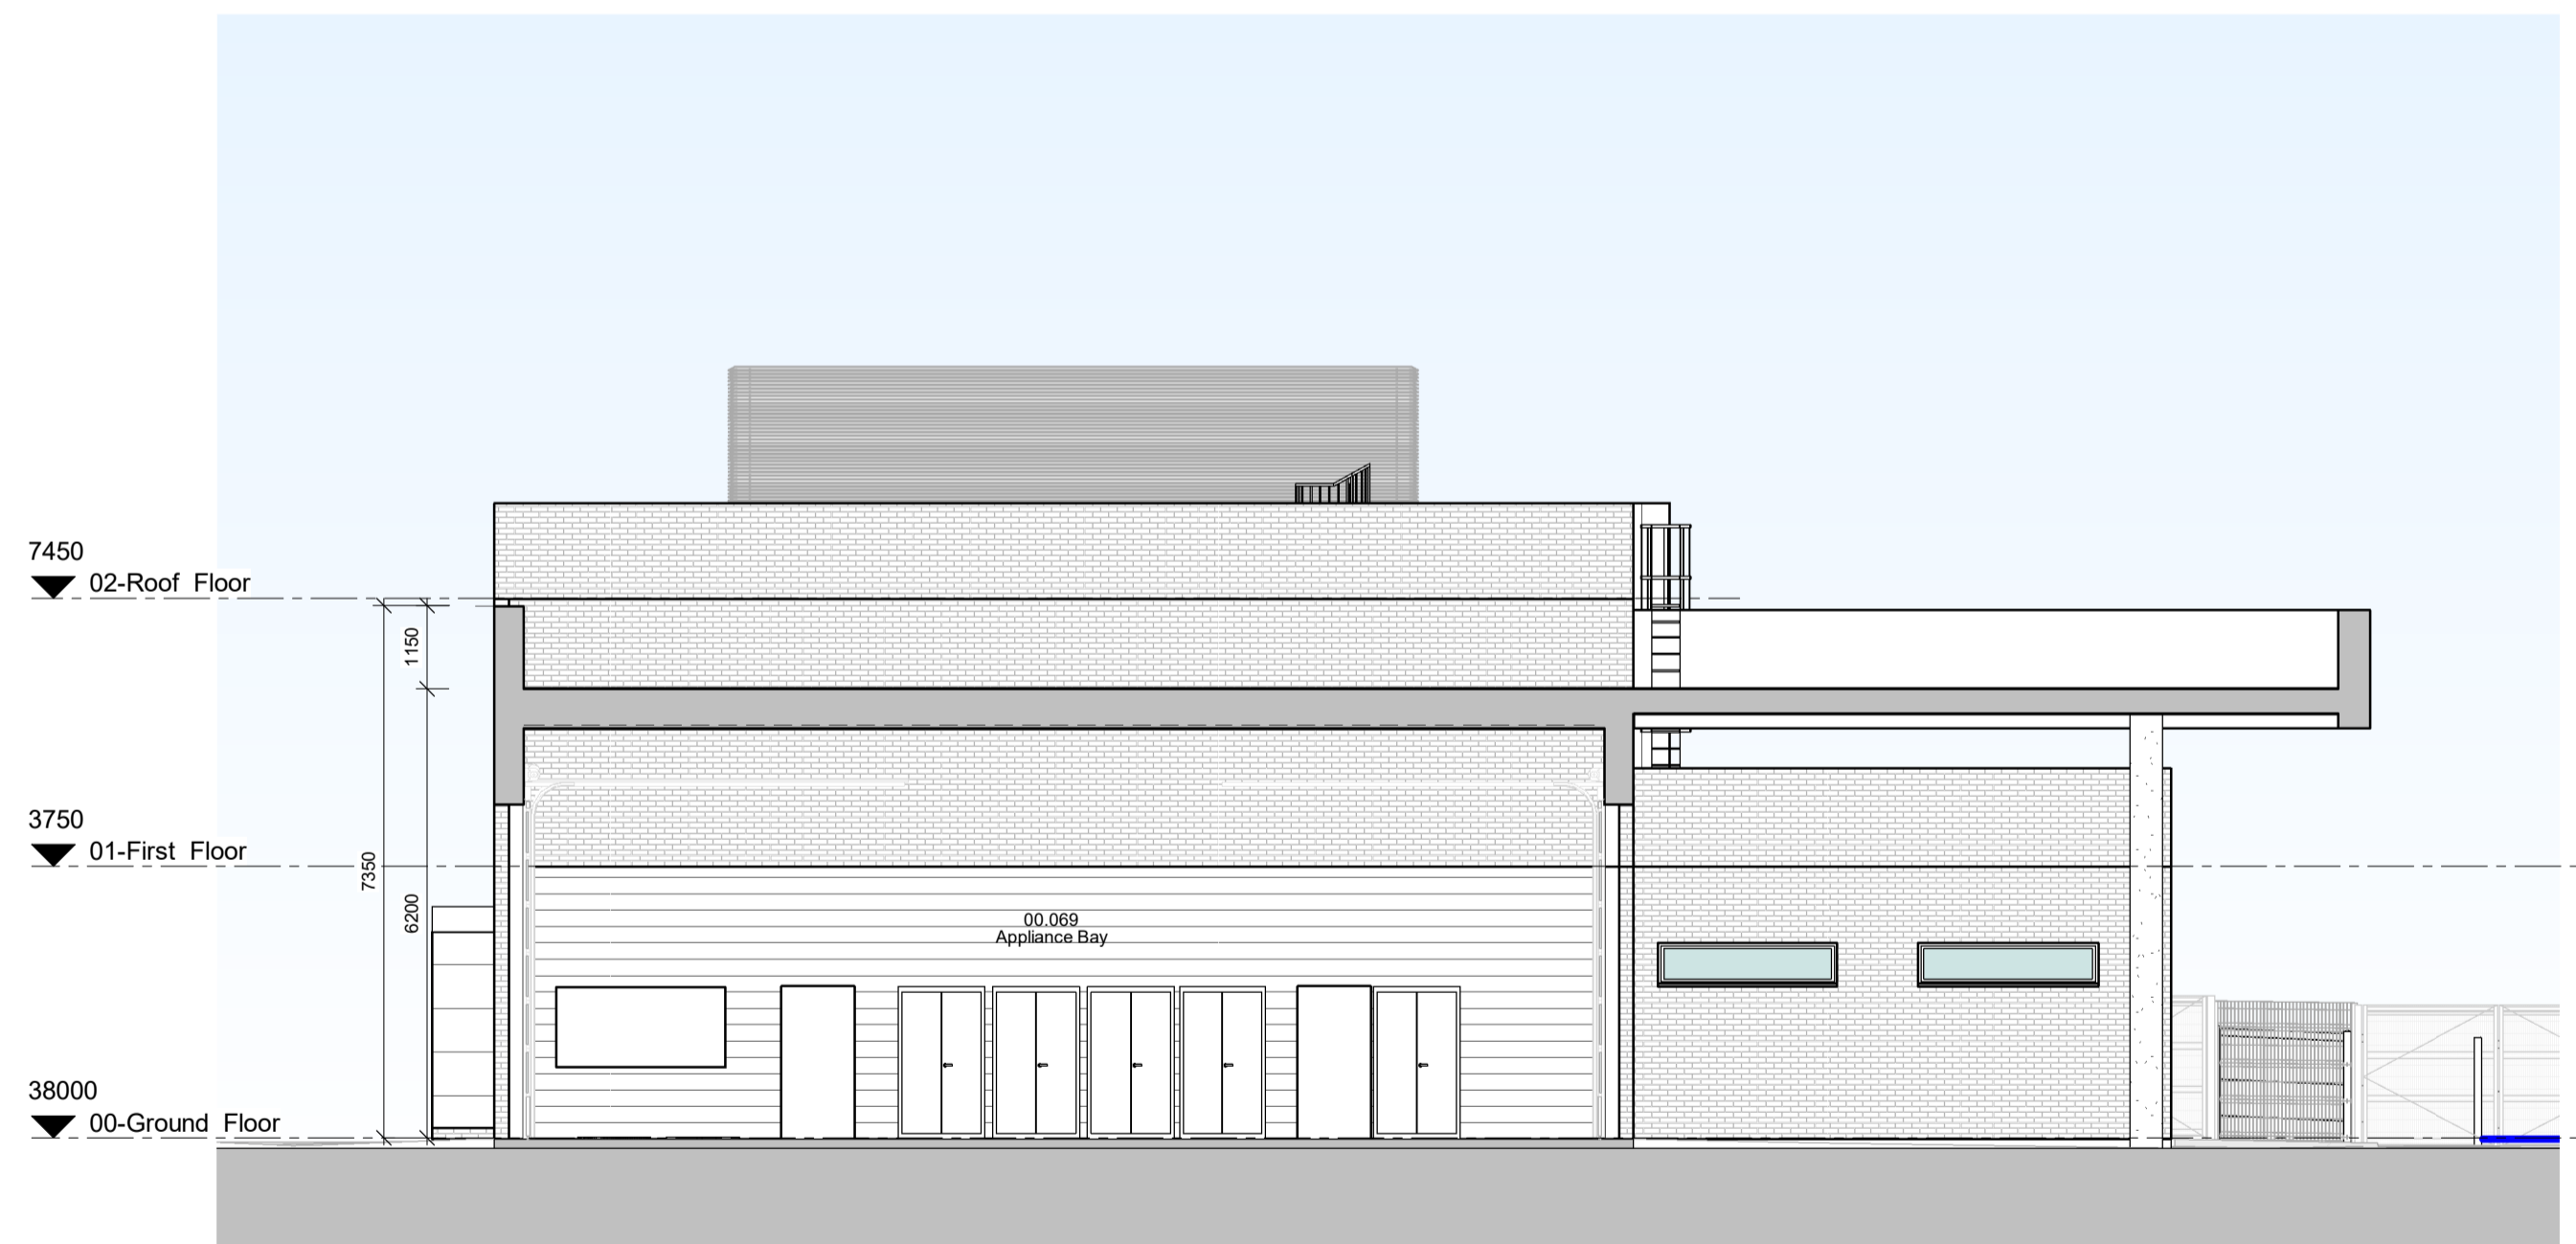

D Building Section D
1 : 100

Note:
Design Proposals require further coordination with Structural, Civil and MEP Engineers

Note:
All measurements are preliminary/ approximate & subject to utilities search, legal boundaries and detailed layouts/design development through consultation.

Note: Coordination
This drawing is subject to further coordination. Resultant amendments may be necessary following receipt and coordination of Consultant/ Building Control/ Fire/ Acoustic Engineer and Subcontractor/ Supplier Information.

Note:
This drawing is to be read in conjunction with all relevant Architectural, Structural, Civil, MEP, and Specialist Subcontractor drawings, specifications schedules and information.



Scale Bar 1:100 @A1

Project			
Willmott Dixon Horsham Fire Station and Training Centre			
Drawn by	Checked by	HNW Project No.	Date Created
TJ	MB	19038	DEC 19
Scale		A1- As indicated	
Drawing Title			
Fire Station and Training Centre - Building Sections			
Drawing status		Revision	
Preliminary		P6	
Drawing Name			
HBC-HNW-FS-ZZ-DR-A-2400			
61 North Street, Chichester, West Sussex, PO19 1NB			

