



- This drawing is the copyright of HNW Architects Ltd No. 3589904
 - All dimensions must be verified on site prior to construction.
 - Do not scale this drawing except for Planning Application purposes.
 - Ordnance Survey Licence No. 100000200
 - Only PDF issues of this drawing are controlled. All other formats of this drawing (e.g. dwg, AutoCAD or .rvt files) are uncontrolled and are used at your own risk.
 - This drawing must not be copied, transmitted or passed to a third party, without written consent.

Rev	Amendments	By	Chkd	Date
P1	Stage 2 Concept Preliminary Issue	MCZ	MB	03/02/2020
P2	Stage 2 - Updated Proposal	TJ	MB	07/02/2020
P3	Updated Proposal	TJ	MB	25/02/2020
P4	DRAFT PLANNING - updated screen	MCZ	MB	19/03/2020
P5	DRAFT PLANNING	TJ	MB	31/03/2020
P6	DRAFT PLANNING	RR	MCZ	26/05/2020
P7	Updated VE Issue / STAGE 3	DH	MCZ	29/05/2020
P8	PLANNING	DH	MCZ	22/09/2020
P9	PLANNING AMENDMENT to capture changes to external screening to South and East facade	WS	MB	02/12/2020

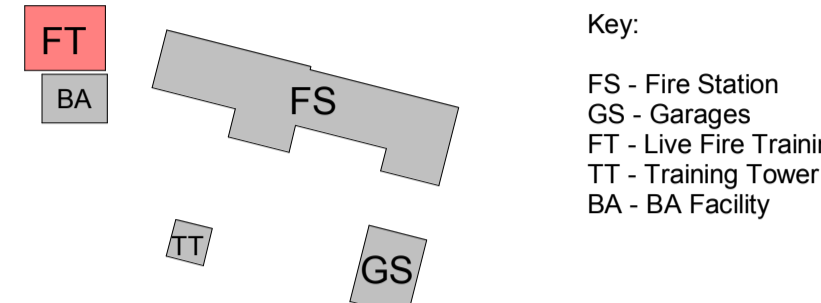


Key - Site Buildings


Key:
 FS - Fire Station
 GS - Garages
 FT - Live Fire Training
 TT - Training Tower
 BA - BA Facility

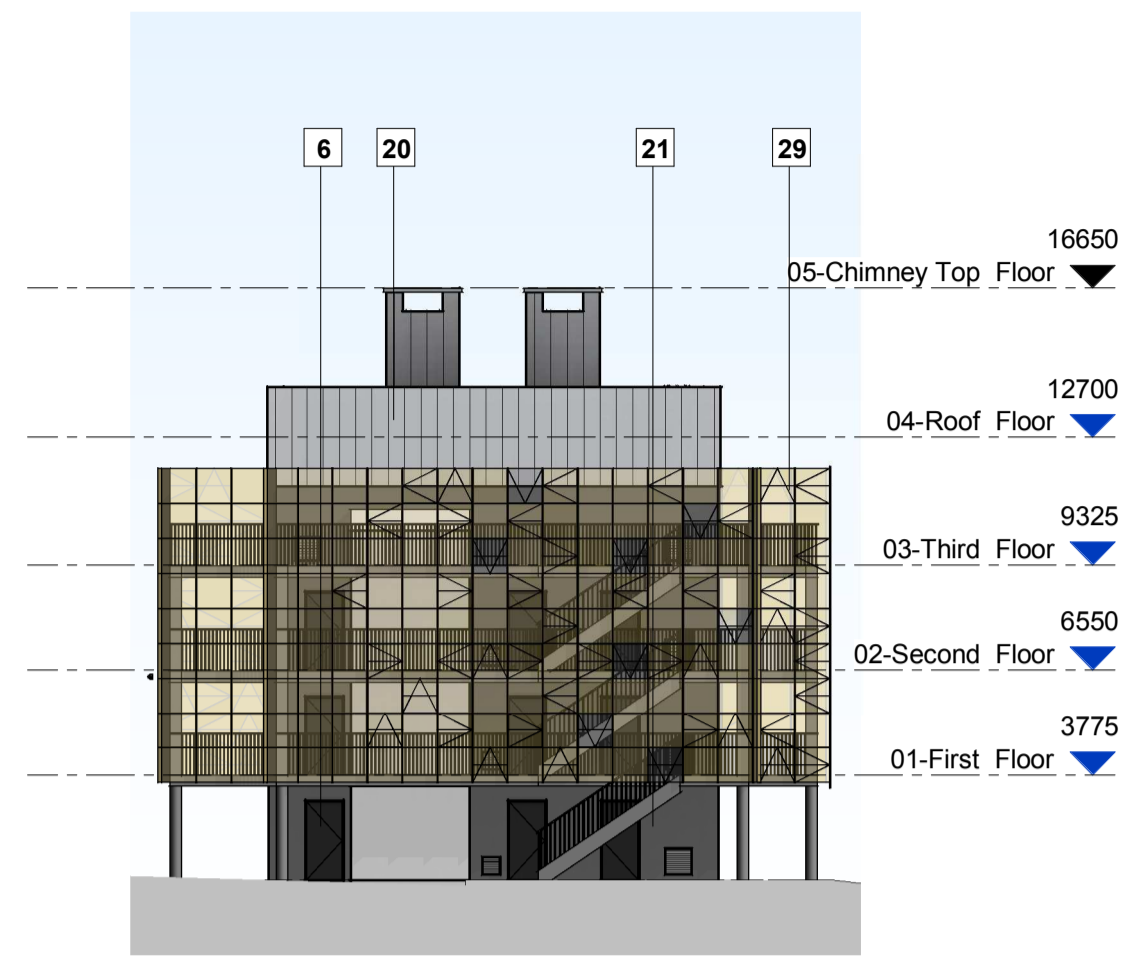


1 Elevation South
1 : 200

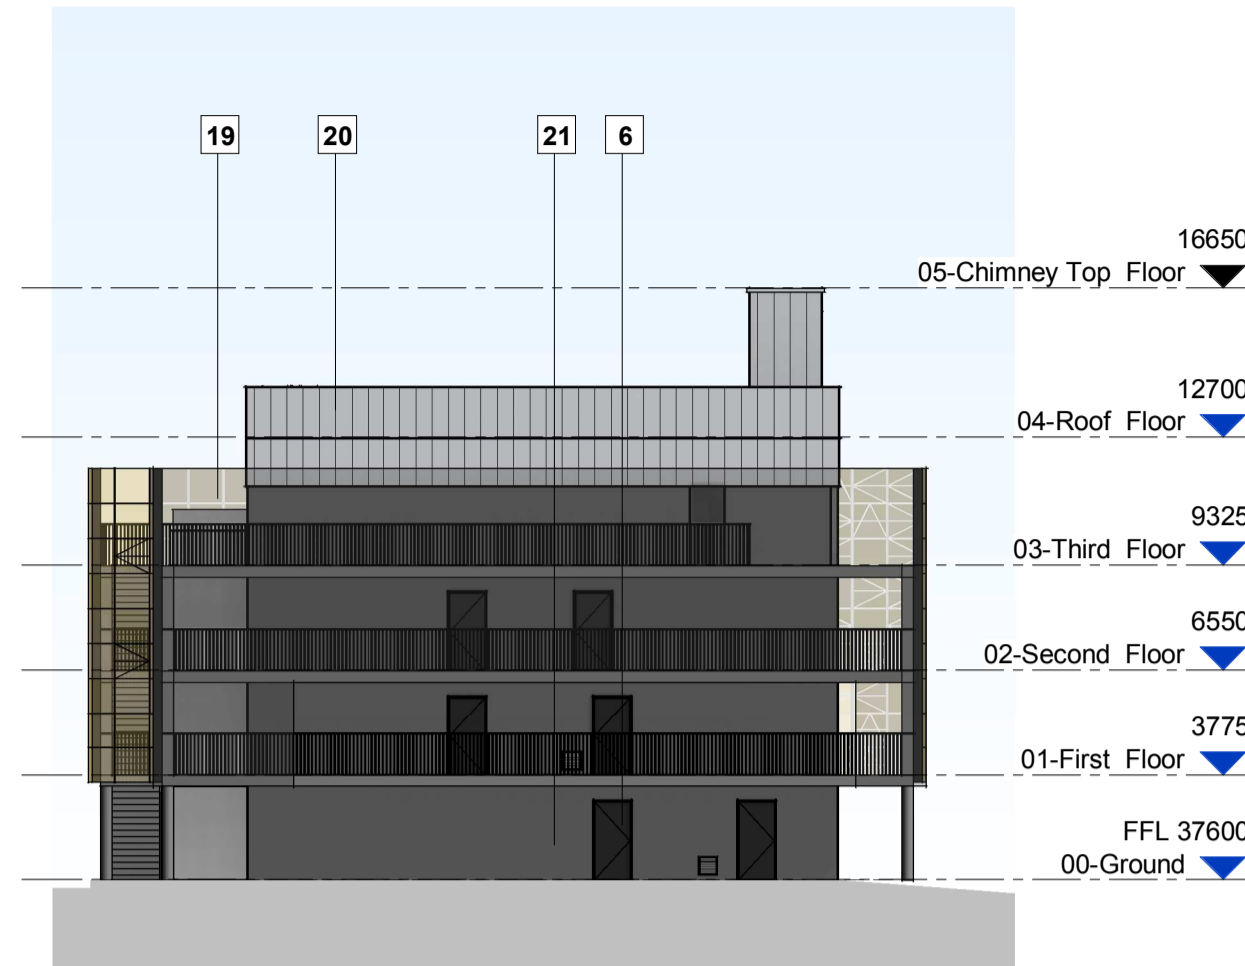

2 Elevation East
1 : 200

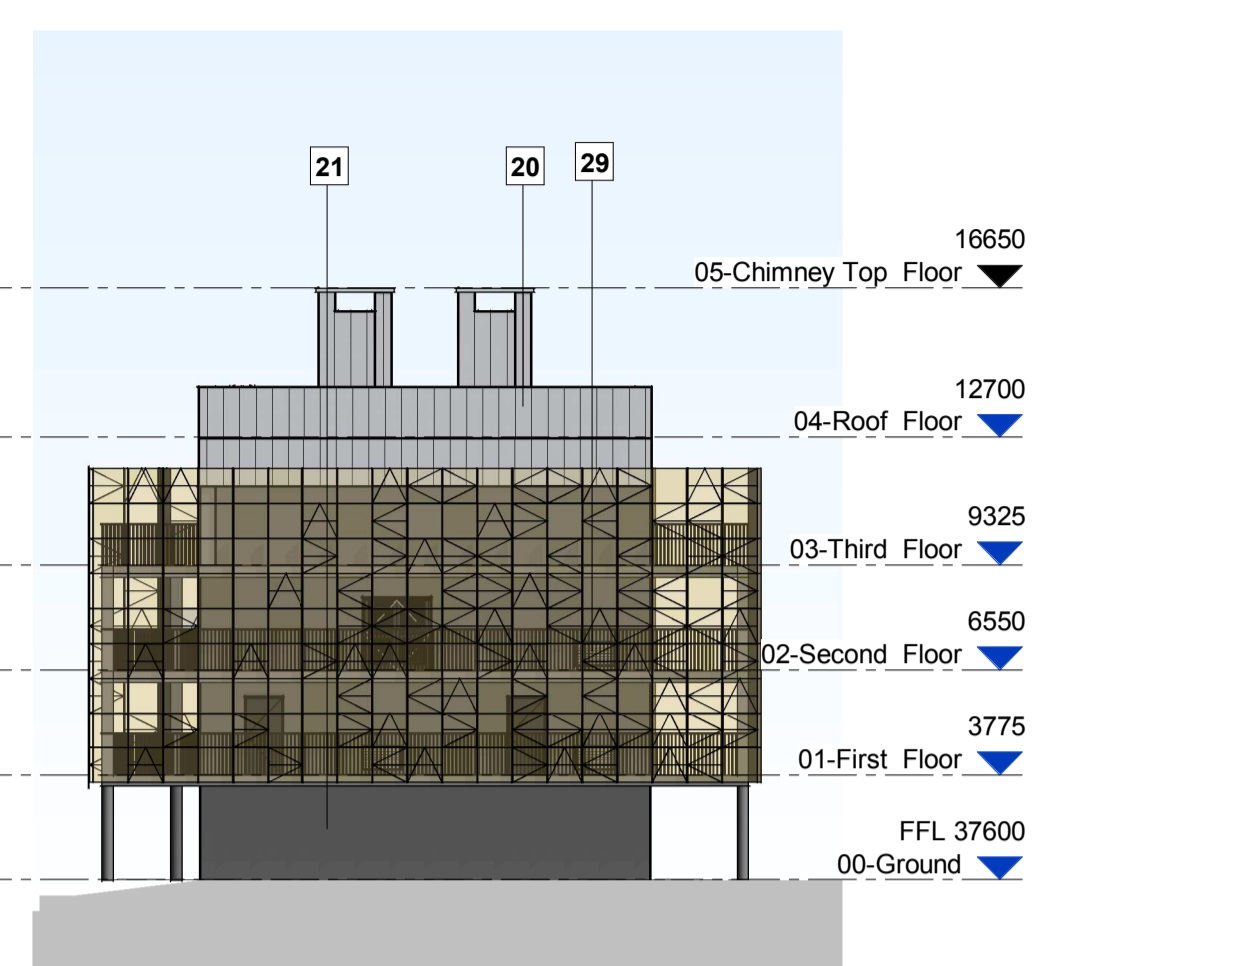


3 Elevation North
1 : 200

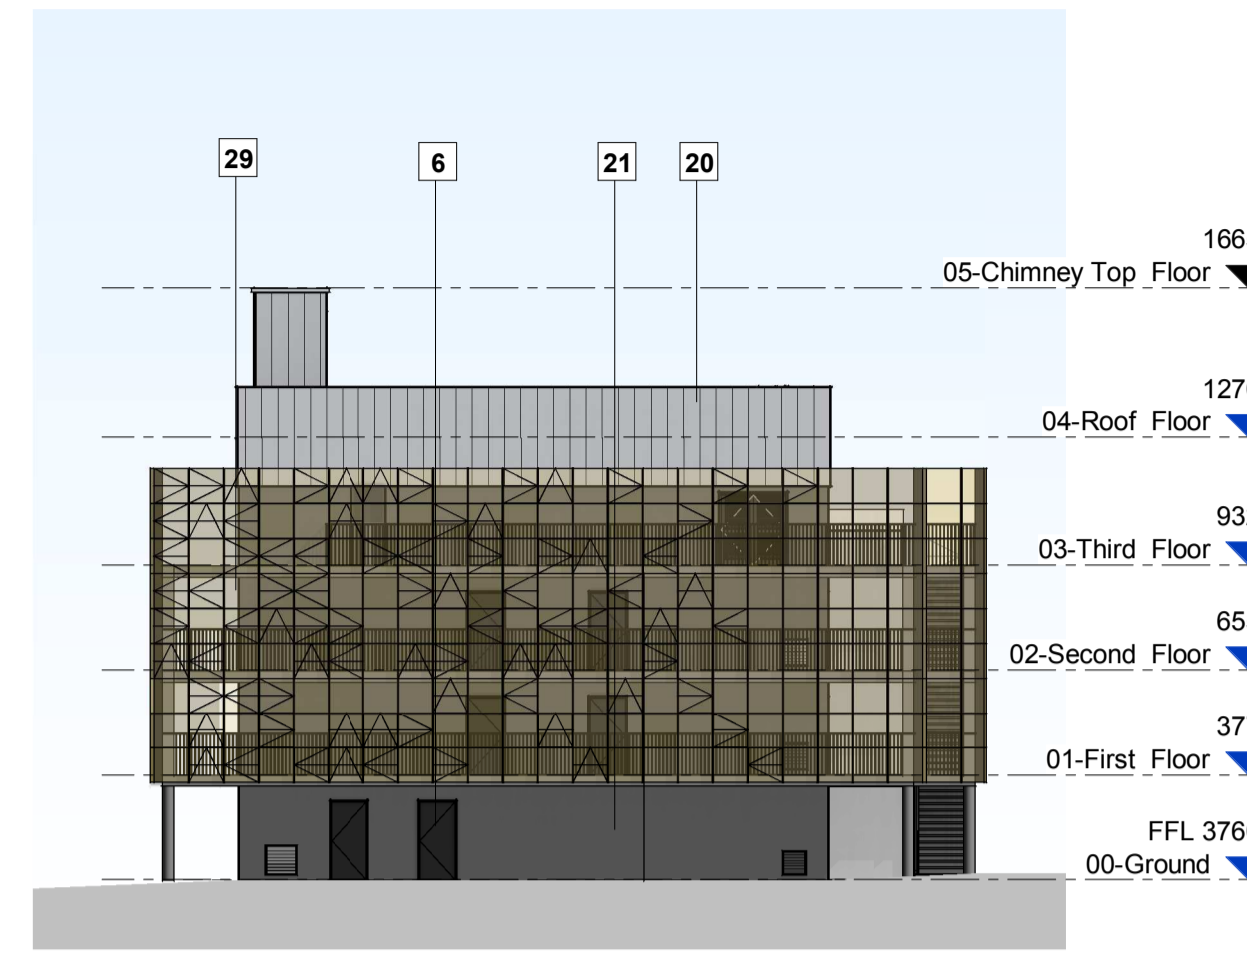


4 Elevation West
1 : 200


Material Schedule	
Tag	Material
6	Metal Door
19	Expanded Metal Mesh
20	Eurobond - Light Grey
21	Blockwork
29	PPC Aluminium Panels - Gold /Bronze: Solid, Perforated and Mixed

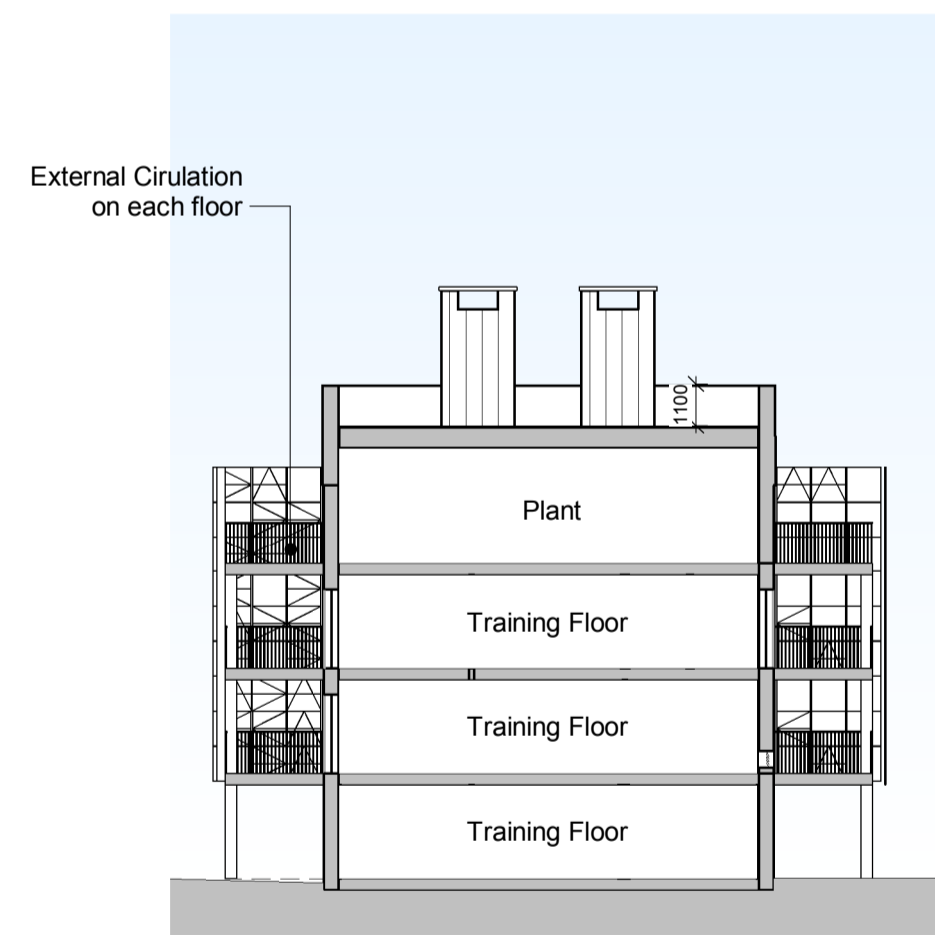

A Section A
1 : 200

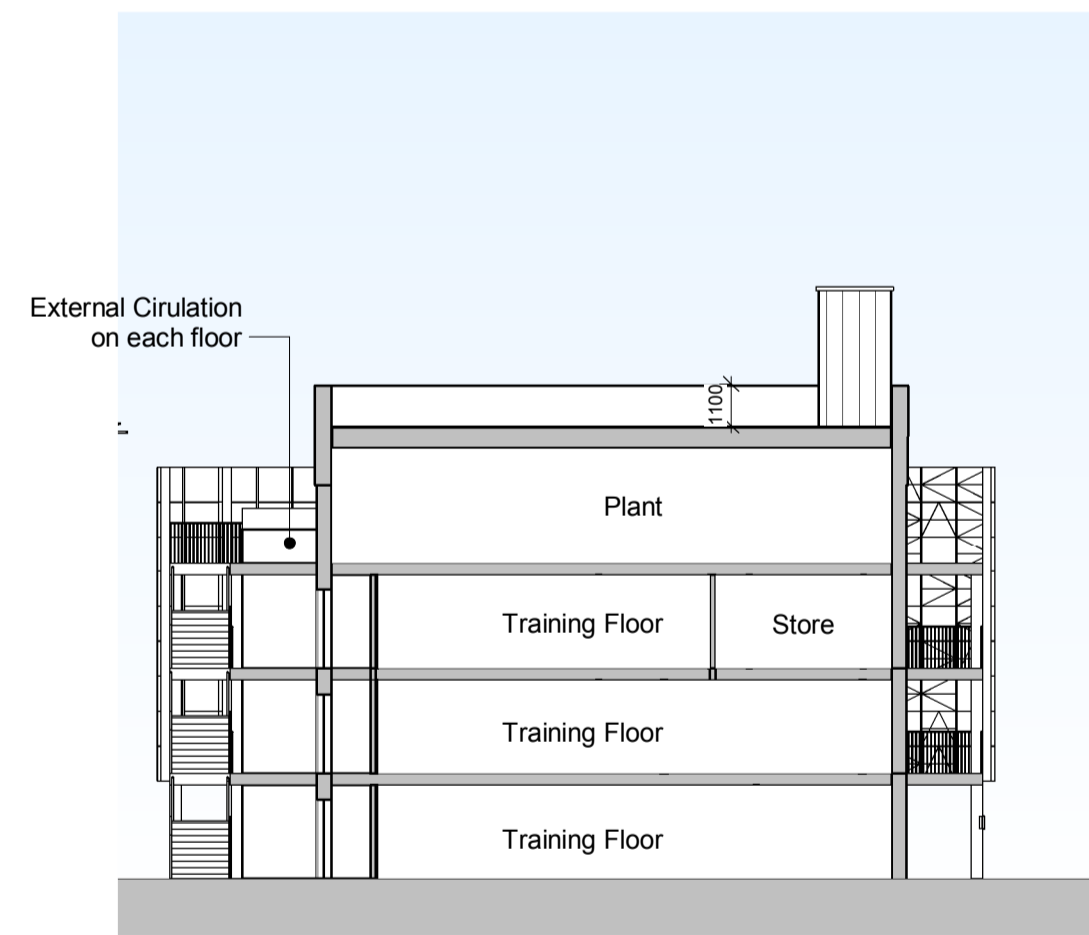

B Section B
1 : 200

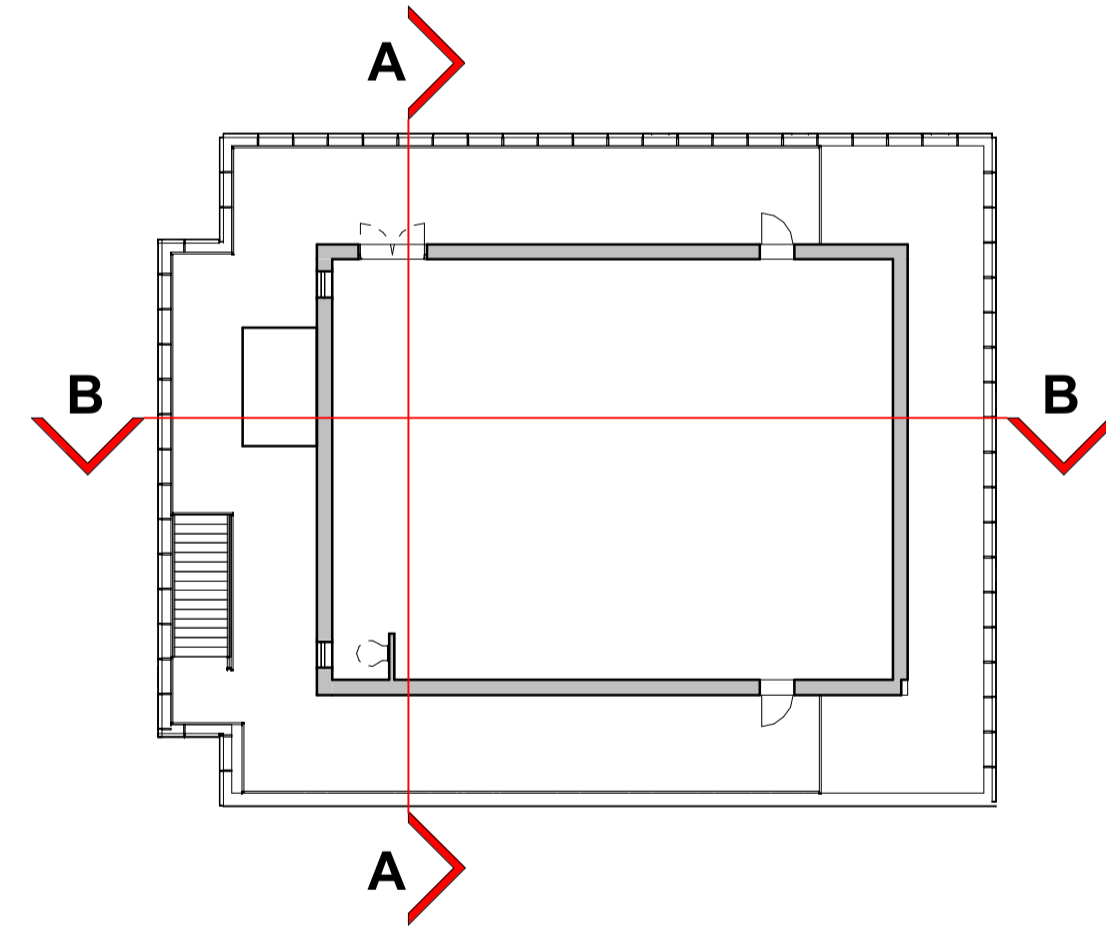


Section Key
1 : 200

Note:
 Proposal requires further coordination with Structural, Civil and MEP Engineers

Note:
 All measurements are preliminary/ approximate & subject to utilities search, legal boundaries and detailed layouts/design development through consultation.

Note: Coordination
 This drawing is subject to further coordination. Resultant amendments may be necessary following receipt and coordination of Consultant/ Building Control/ Fire/ Acoustic Engineer and Subcontractor/ Supplier Information.

 Note:
 This drawing is to be read in conjunction with all relevant Architectural, Structural, Civil, MEP, and Specialist Subcontractor drawings, specifications schedules and information.



Scale Bar 1:200@A1

Project
 Willmott Dixon
 Horsham Fire Station

Drawn by TJ Checked by MB HNW Project No. 19038 Date Created JAN 2020

Scale
 A1- As indicated

Drawing Title
 Live Fire Training Facility - Elevations and Sections


Drawing status Preliminary Revision P9

Drawing Name
 HBC-HNW-FT-ZZ-DR-A-2301


61 North Street, Chichester, West Sussex, PO19 1NB

- This drawing is the copyright of HNW Architects Ltd No. 3589904
 - All dimensions must be verified on site prior to construction.
 - Do not scale this drawing except for Planning Application purposes.
 - Ordnance Survey Licence No. 100000200
 - Only PDF issues of this drawing are controlled. All other formats of this drawing (e.g. dwg, autocad or rvt Revit files) are un-controlled and are used at your own risk.
 - This drawing must not be copied, transmitted or passed to a third party, without written consent


Rev	Amendments	By	Chkd	Date
P1	Stage 2 Concept Preliminary Issue	TJ	MB	17/12/2020
P2	Stage 2 - Updated Proposal	TJ	MB	07/02/2020
P3	DRAFT PLANNING - updated screen	MCZ	MB	19/03/2020
P4	DRAFT PLANNING	TJ	MB	31/03/2020
P5	DRAFT PLANNING	RR	MCZ	26/05/2020
P6	Updated VE Issue / STAGE 3	DH	MCZ	29/05/2020
P7	PLANNING	DH	MCZ	22/09/2020
P8	PLANNING AMENDMENT to capture changes to external screening to South and East facade	WS	MB	02/12/2020

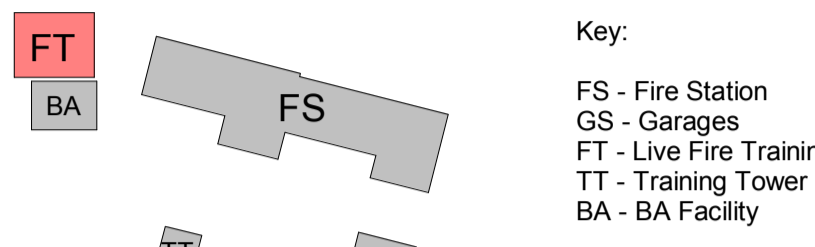


Key - Site Buildings

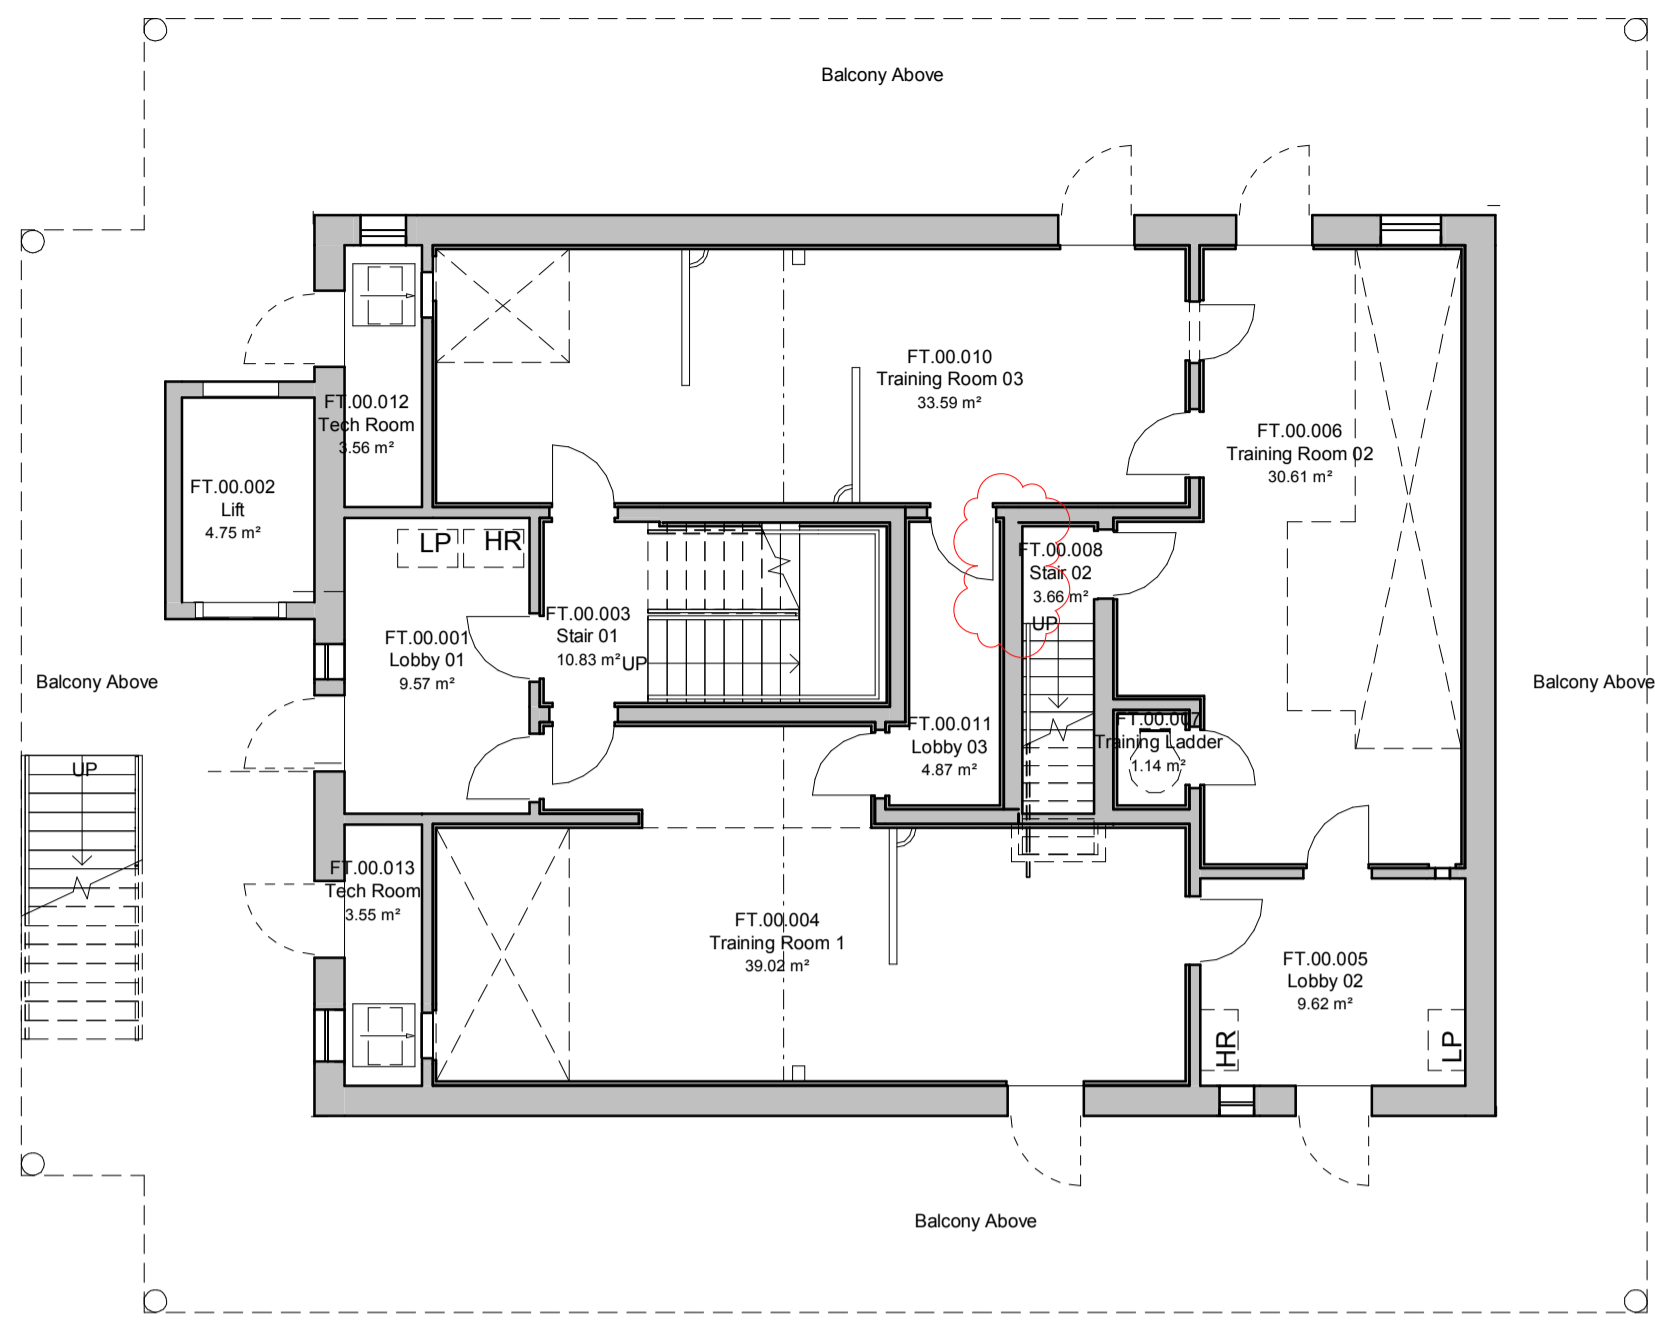


Ground Floor Plan
1 : 100

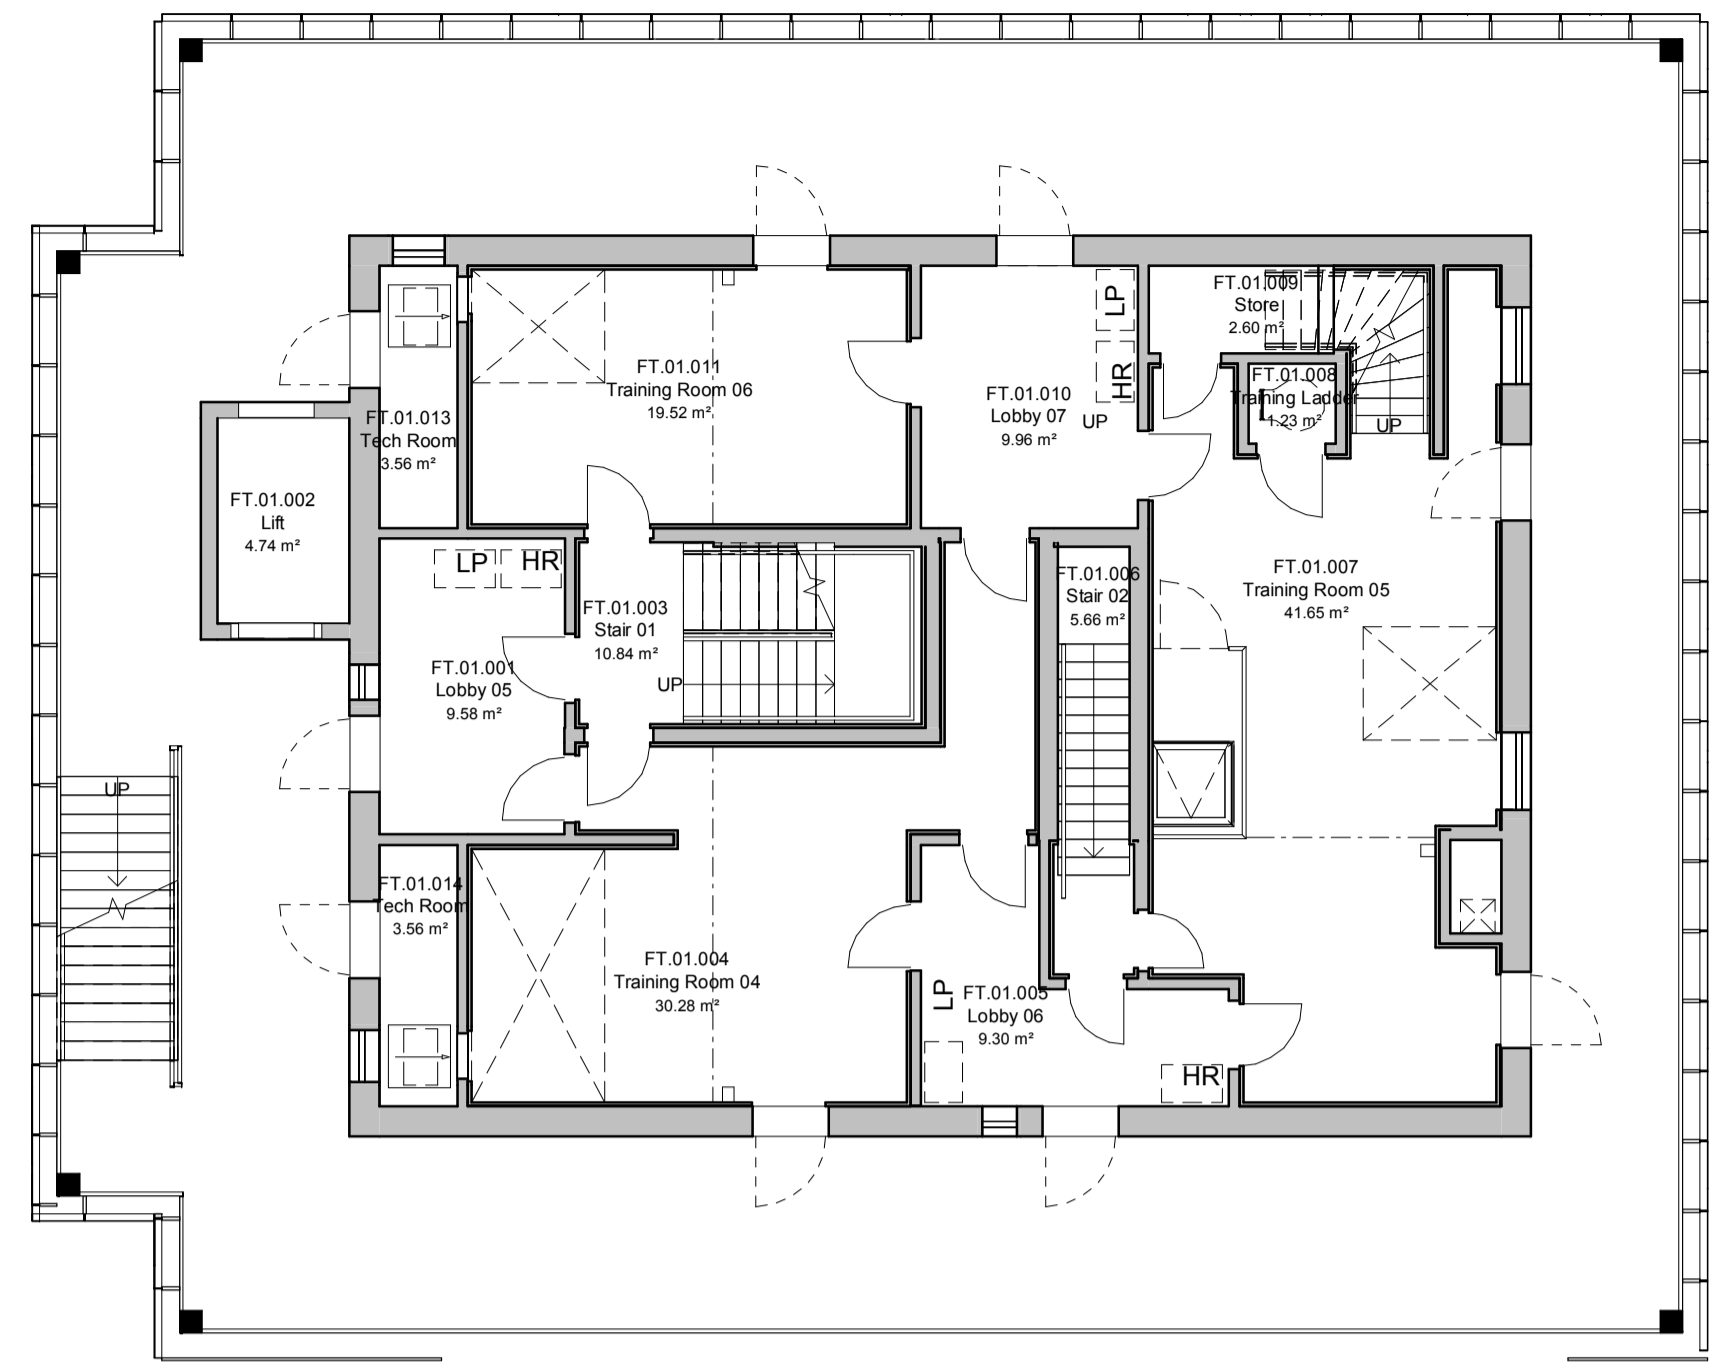


First Floor Plan
1 : 100

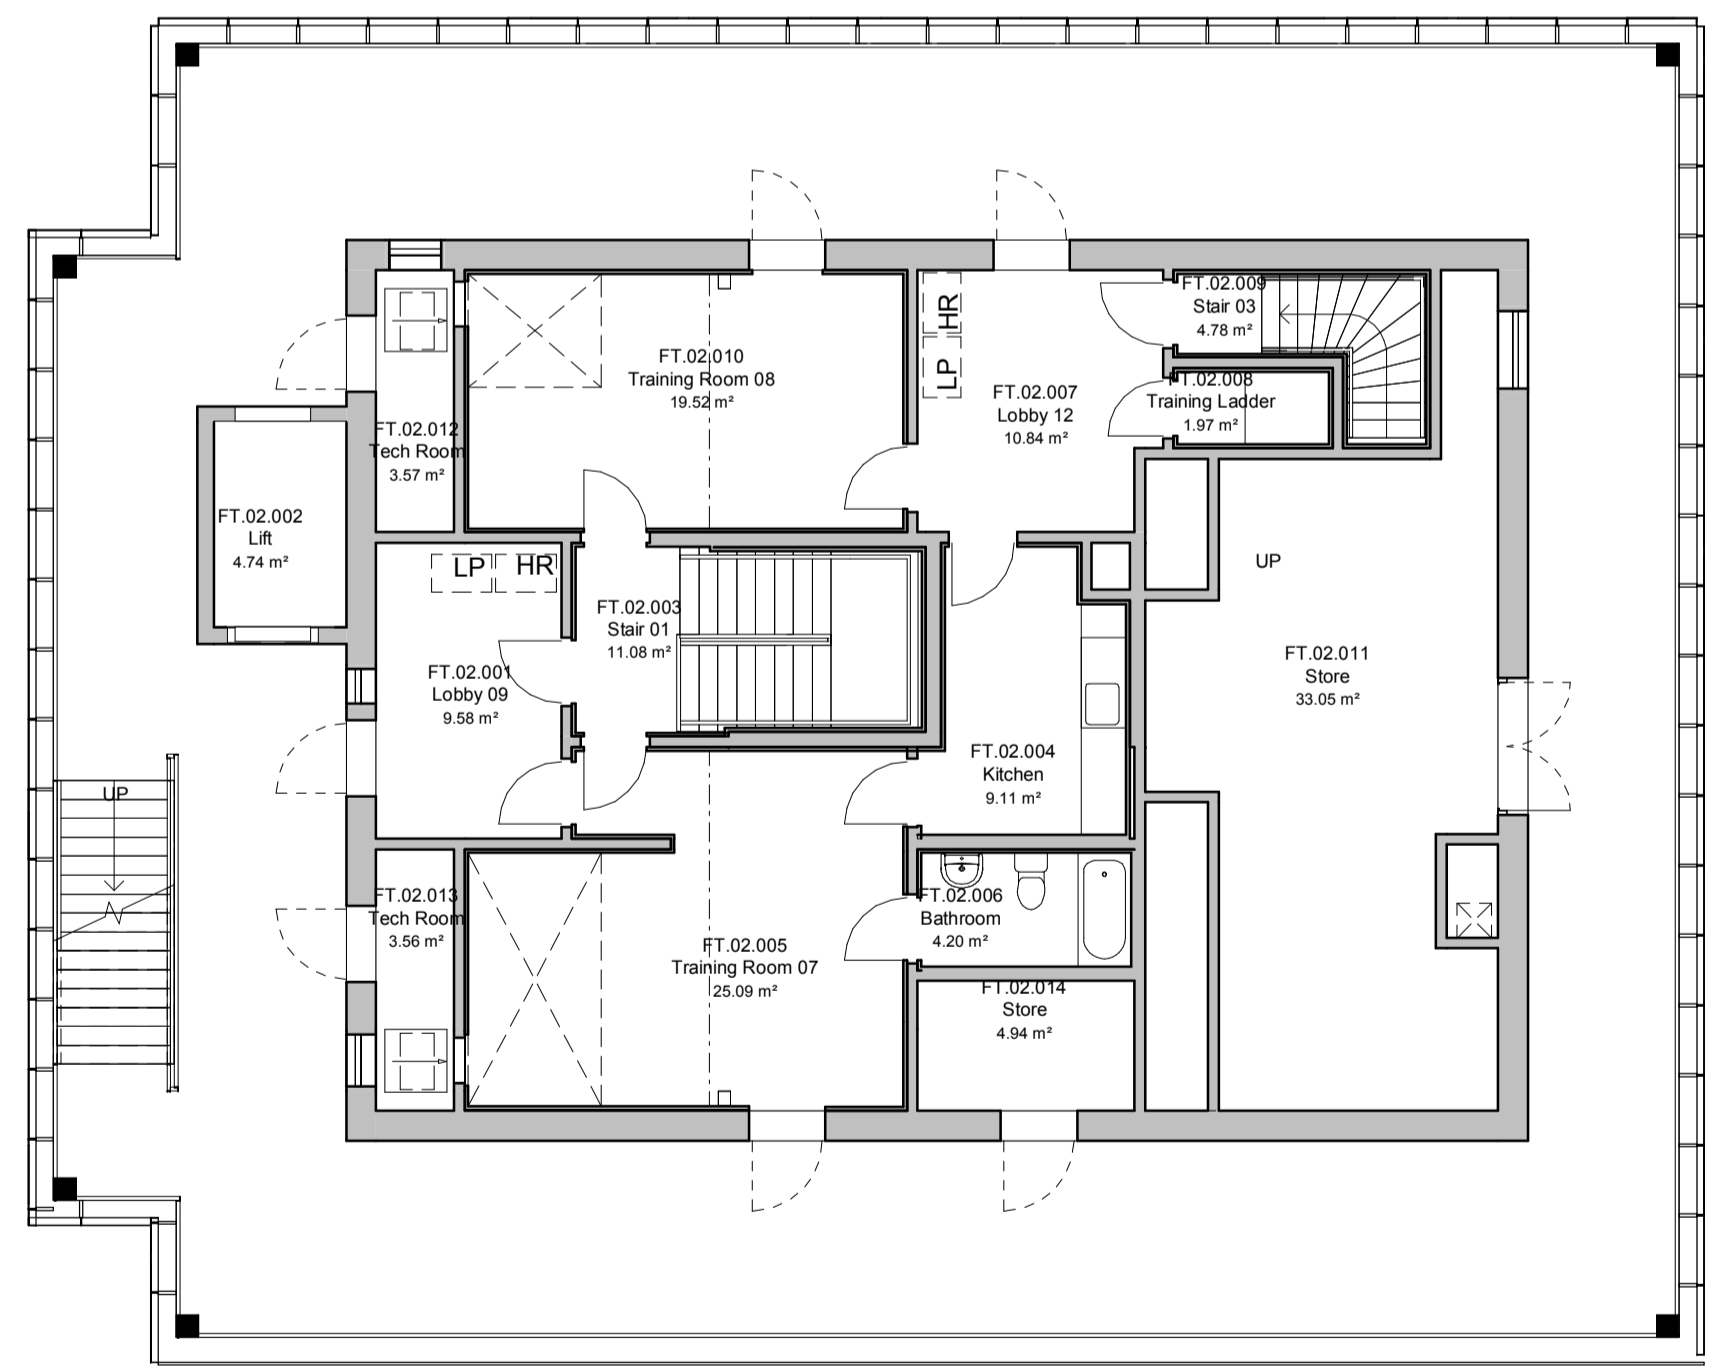

Second Floor Plan
1 : 100

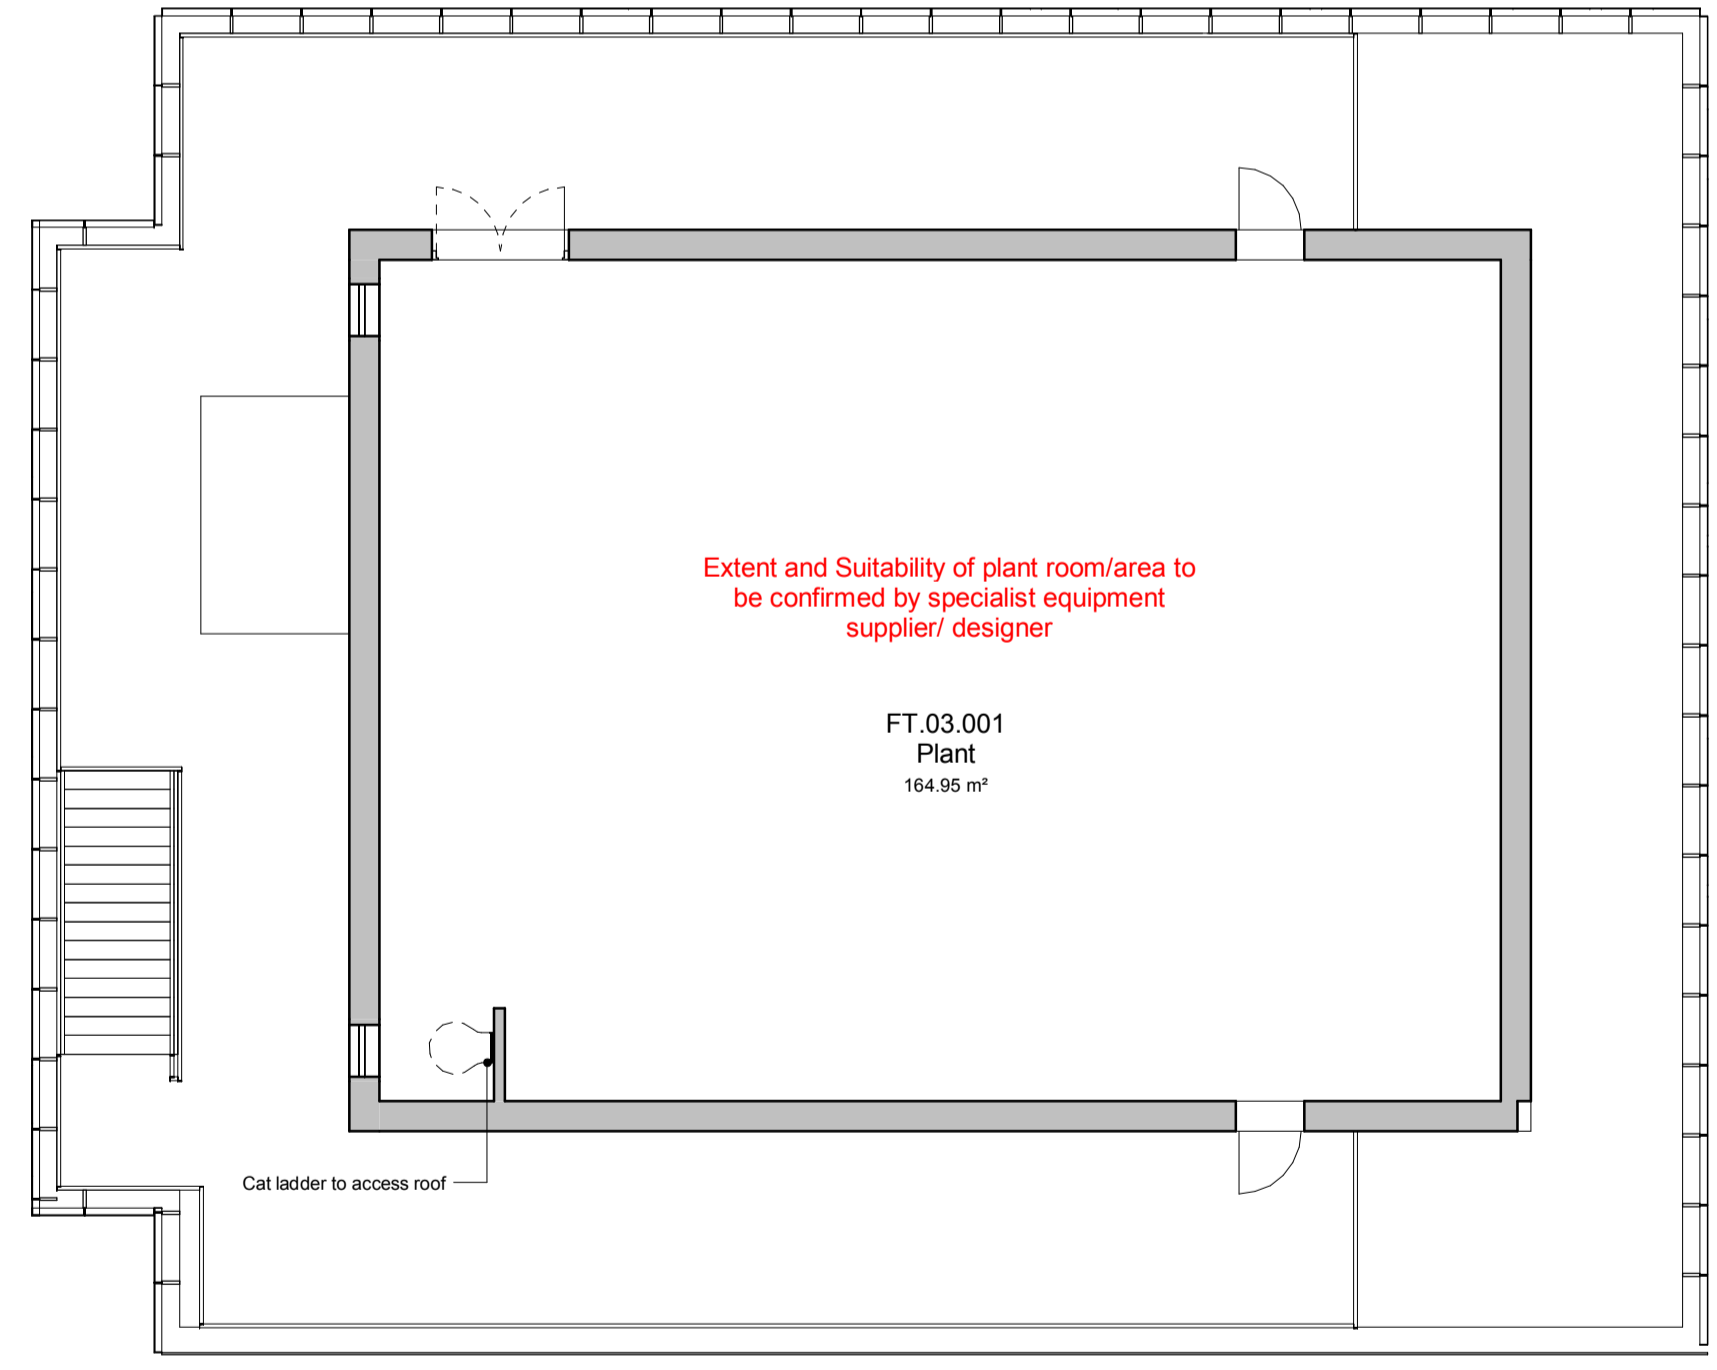

Third Floor Plan
1 : 100

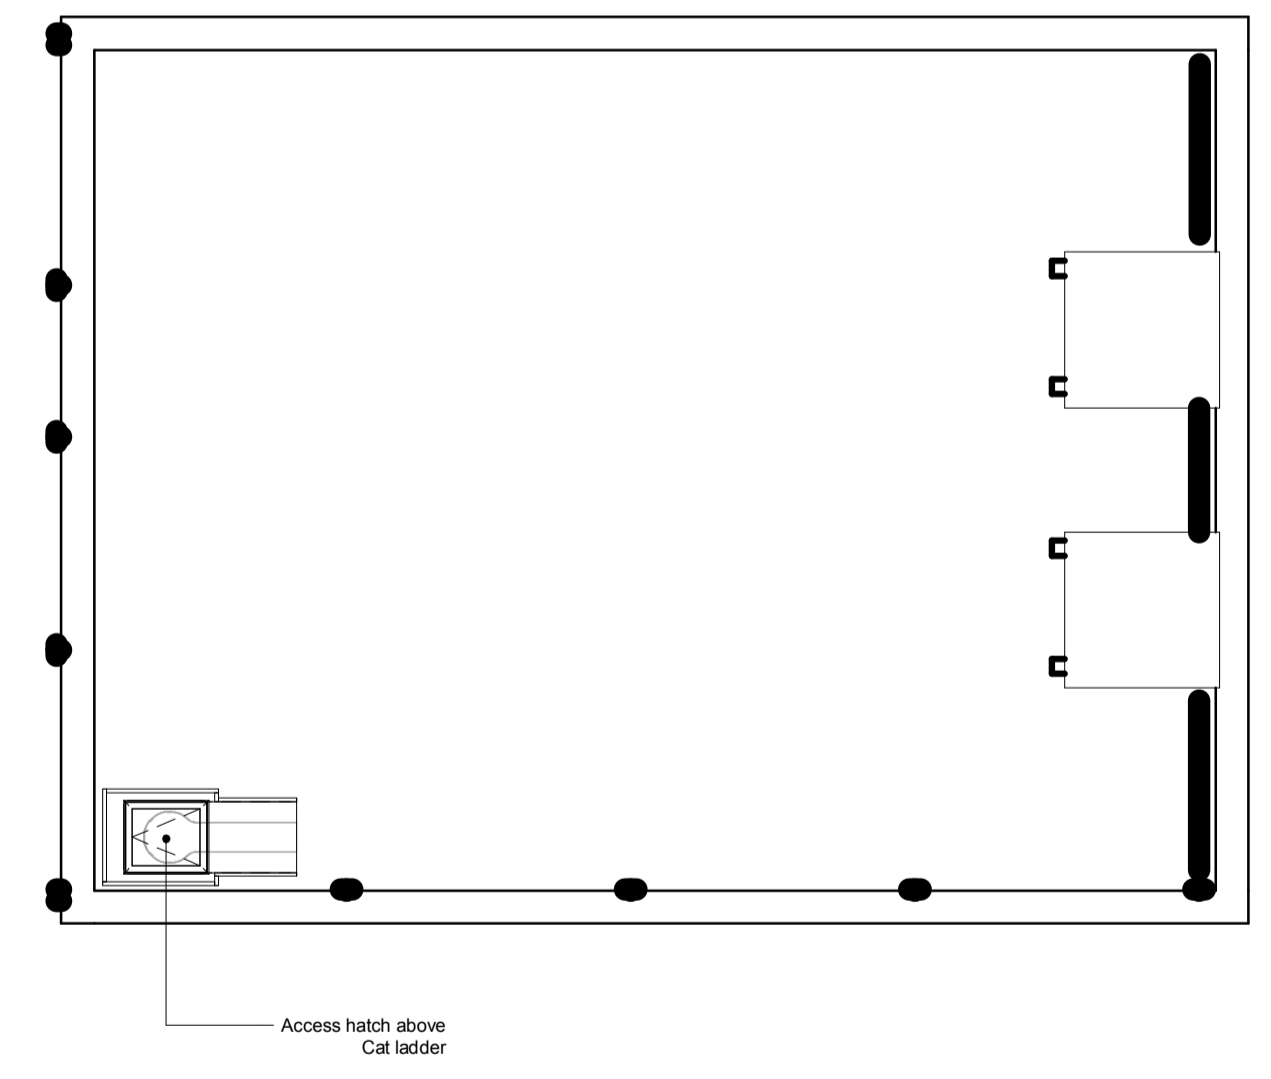


Roof Plan
1 : 100

Note:
 Proposal requires further coordination with Structural, Civil and MEP Engineers

Note:
 All measurements are preliminary/ approximate & subject to utilities search, legal boundaries and detailed layouts/design development through consultation.

Note: Coordination
 This drawing is subject to further coordination. Resultant amendments may be necessary following receipt and coordination of Consultant/ Building Control/ Fire/ Acoustic Engineer and Subcontractor/ Supplier Information.

 Note:
 This drawing is to be read in conjunction with all relevant Architectural, Structural, Civil, MEP, and Specialist Subcontractor drawings, specifications schedules and information.



Scale Bar 1:100 @A1

Project
 Willmott Dixon
 Horsham Fire Station

Drawn by	Checked by	HNW Project No.	Date Created
TJ	MB	19038	JAN 2020

Scale
 A1- As indicated

Drawing Title
 Live Fire Training Facility - Floor Plans

Drawing status	Revision
Preliminary	P8


Drawing Name
 HBC-HNW-FT-ZZ-DR-A-2200

61 North Street, Chichester, West Sussex, PO19 3NB



Existing Proposal

Grey Expanded Mesh Cladding to South Stair Core

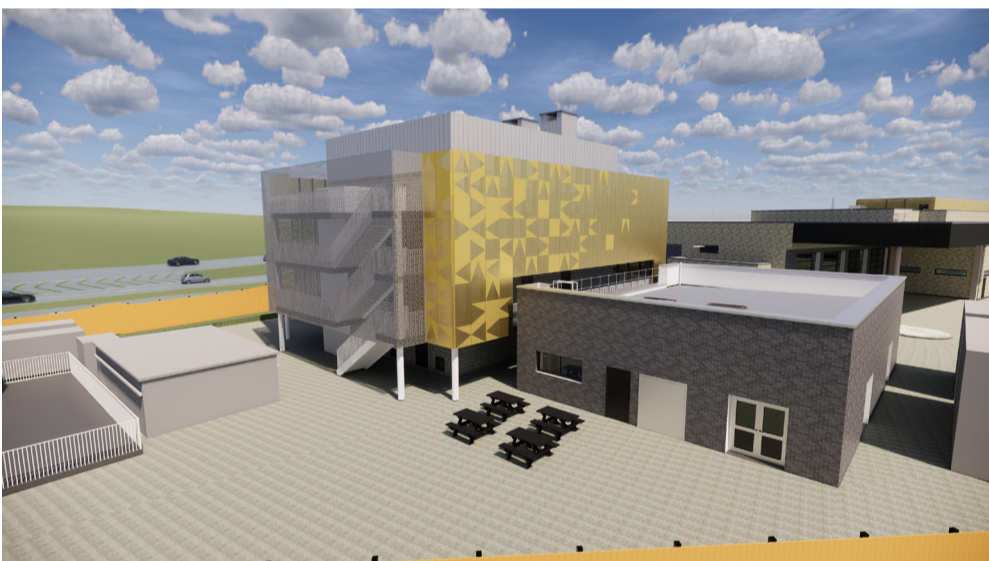

Design Option 1

Grey Expanded Mesh Cladding to East Elevation

